


McQuaide Trucking/MCS Logistics - Acquire Trucking System Project - Acquire Site Plan - C-3 LAYOUT AND DIMENSIONING PLAN - 08/2008 - 2007 - 27 - PA - DIM TO 10' 0"

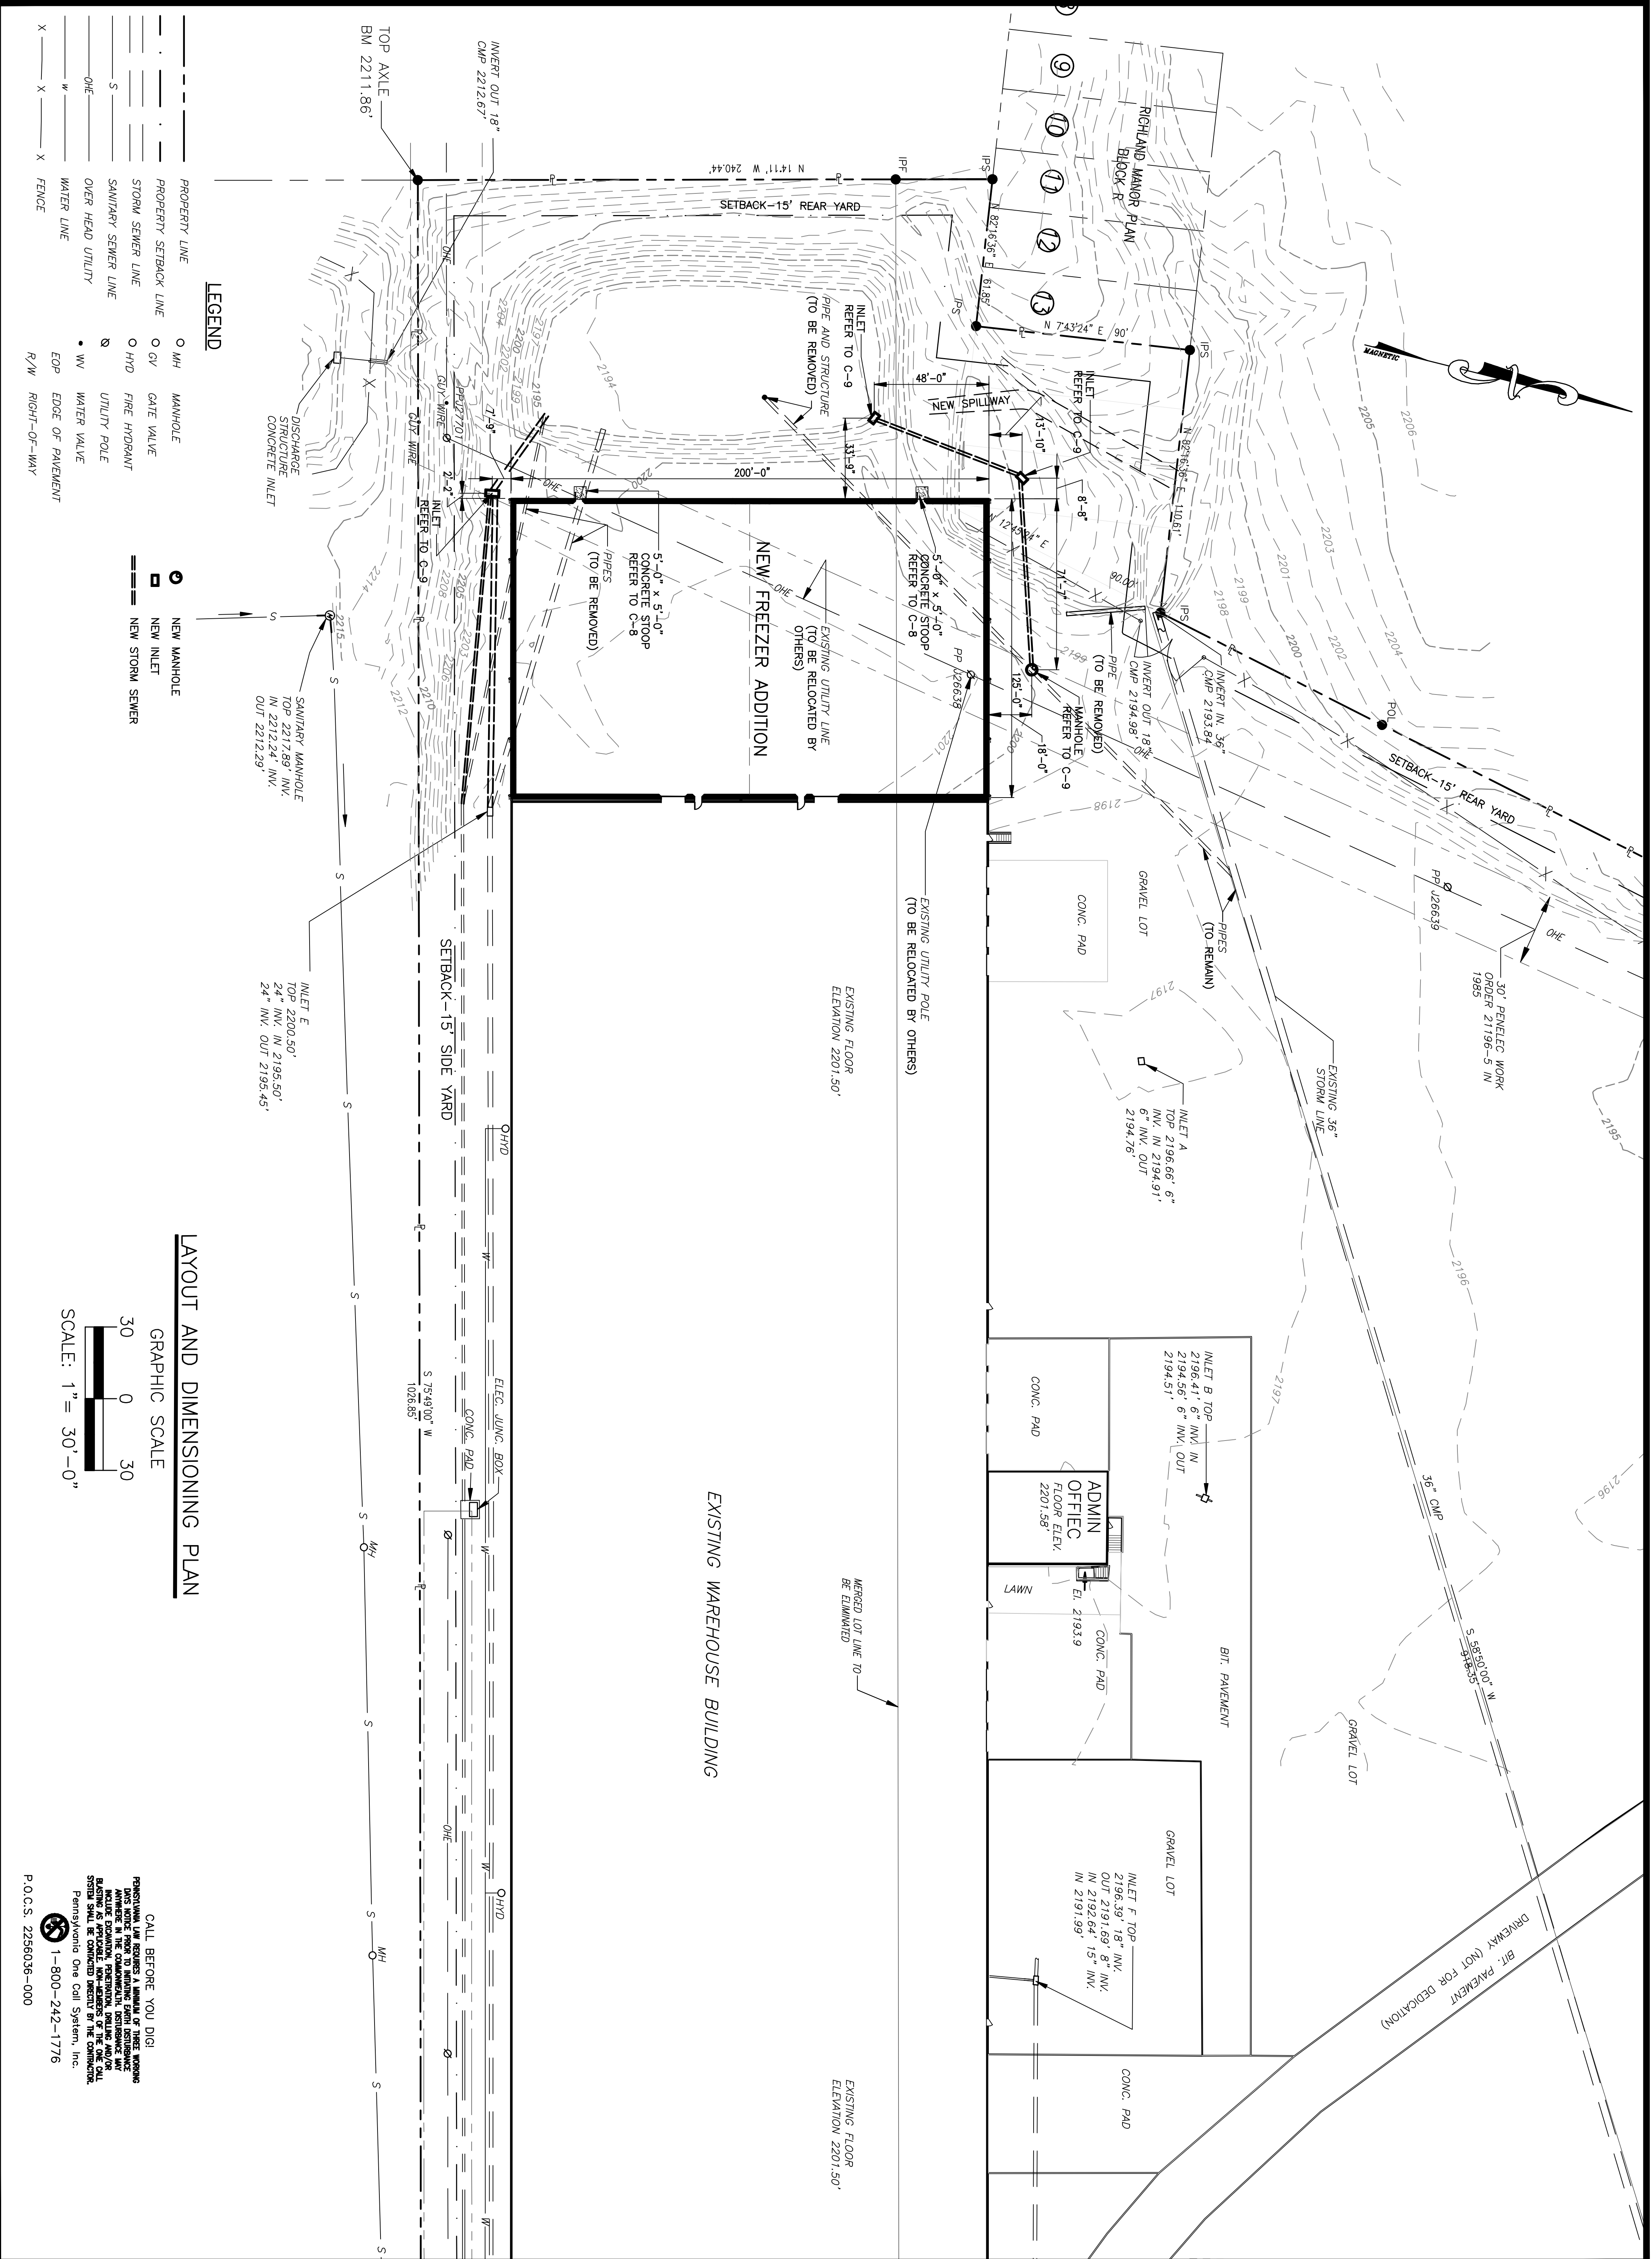


LEGEND

- — — — — PROPERTY LINE
- — — — — PROPERTY SETBACK LINE
- — — — — STORM SEWER LINE
- — — — — SANITARY SEWER LINE
- — — — — OVER HEAD UTILITY
- — — — — WATER LINE
- — — — — FENCE
- MH MANHOLE
- GV GATE VALVE
- HYD FIRE HYDRANT
- UTILITY POLE
- WATER VALVE
- — — — — EOP EDGE OF PAVEMENT
- R/W RIGHT-OF-WAY
- NEW MANHOLE
- NEW INLET
- — — — — NEW STORM SEWER

LAYOUT AND DIMENSIONING PLAN

GRAPHIC SCALE

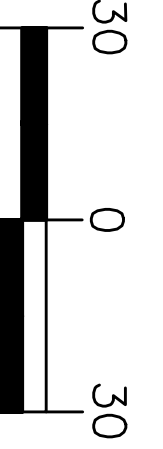

SCALE: 1" = 30'-0"

CALL BEFORE YOU DIG!
 PENNSYLVANIA HAS A STATE-OPERATED PUBLIC SAFETY SERVICE
 THAT PROVIDES A 24-HOUR SERVICE TO ASSIST YOU IN
 LOCATING UTILITIES PRIOR TO ANY EXCAVATION WORK.
 CONTACT THE COMMONWEALTH DISTRICTANCE AND
 PLANNING DEPARTMENT AT 1-800-488-7243 FOR
 A FREE INFORMATIONAL BROCHURE.
 PENNSYLVANIA ONE CALL SYSTEM, INC.
 P.O.C.S. 2256036-000

McQUAIDE TRUCKING/MCS LOGISTICS
NEW BUILDING ADDITION PROJECT
153 MACRIDGE AVENUE
RICHLAND TOWNSHIP, PA 15904
 A CORLE BUILDING SYSTEMS / CORLE CONSTRUCTION PROJECT
LAYOUT AND DIMENSIONING PLAN

THE EADS GROUP
 AN INFRASTRUCTURE DESIGN-BUILD FIRM
450 ABERDEEN DRIVE
SOMERSET, PA 15501
 WITH OFFICES IN:
 ALTOONA, PA
 PITTSBURGH, PA
 SOMERSET, PA
 CUMBERLAND, MD.
 Phone: 814-445-8851
 Fax: 814-443-2748
 www.eadsgroup.com

Approved By: _____ Date: _____
 Approved By: _____ Date: _____
 Copyrighted by The EADS Group Inc.
 The information contained herein may not be
 used or copied in any manner without the
 written permission of The EADS Group, Inc.

Seal: _____
 Seal: _____

Scale: 1" = 30'-0"
 Date: SEPTEMBER 2008
 Drawn By: S.R.M.
 Checked By: G.L.E.
 Project No.: 0380-08-008.30
 File No.: PP_0-1 EXISTING CONDITION SITE DEAD

Revised Dates
 NOTE: DO NOT SCALE DRAWINGS
 DIMENSIONS ARE TO VERIFY ALL
 DIMENSIONS AND CONDITIONS ARE
 AS SHOWN ON THIS DRAWING

